


CONTROL

24ch Decoder - A

@ 22/01

STOCK CESSNA PORTAL

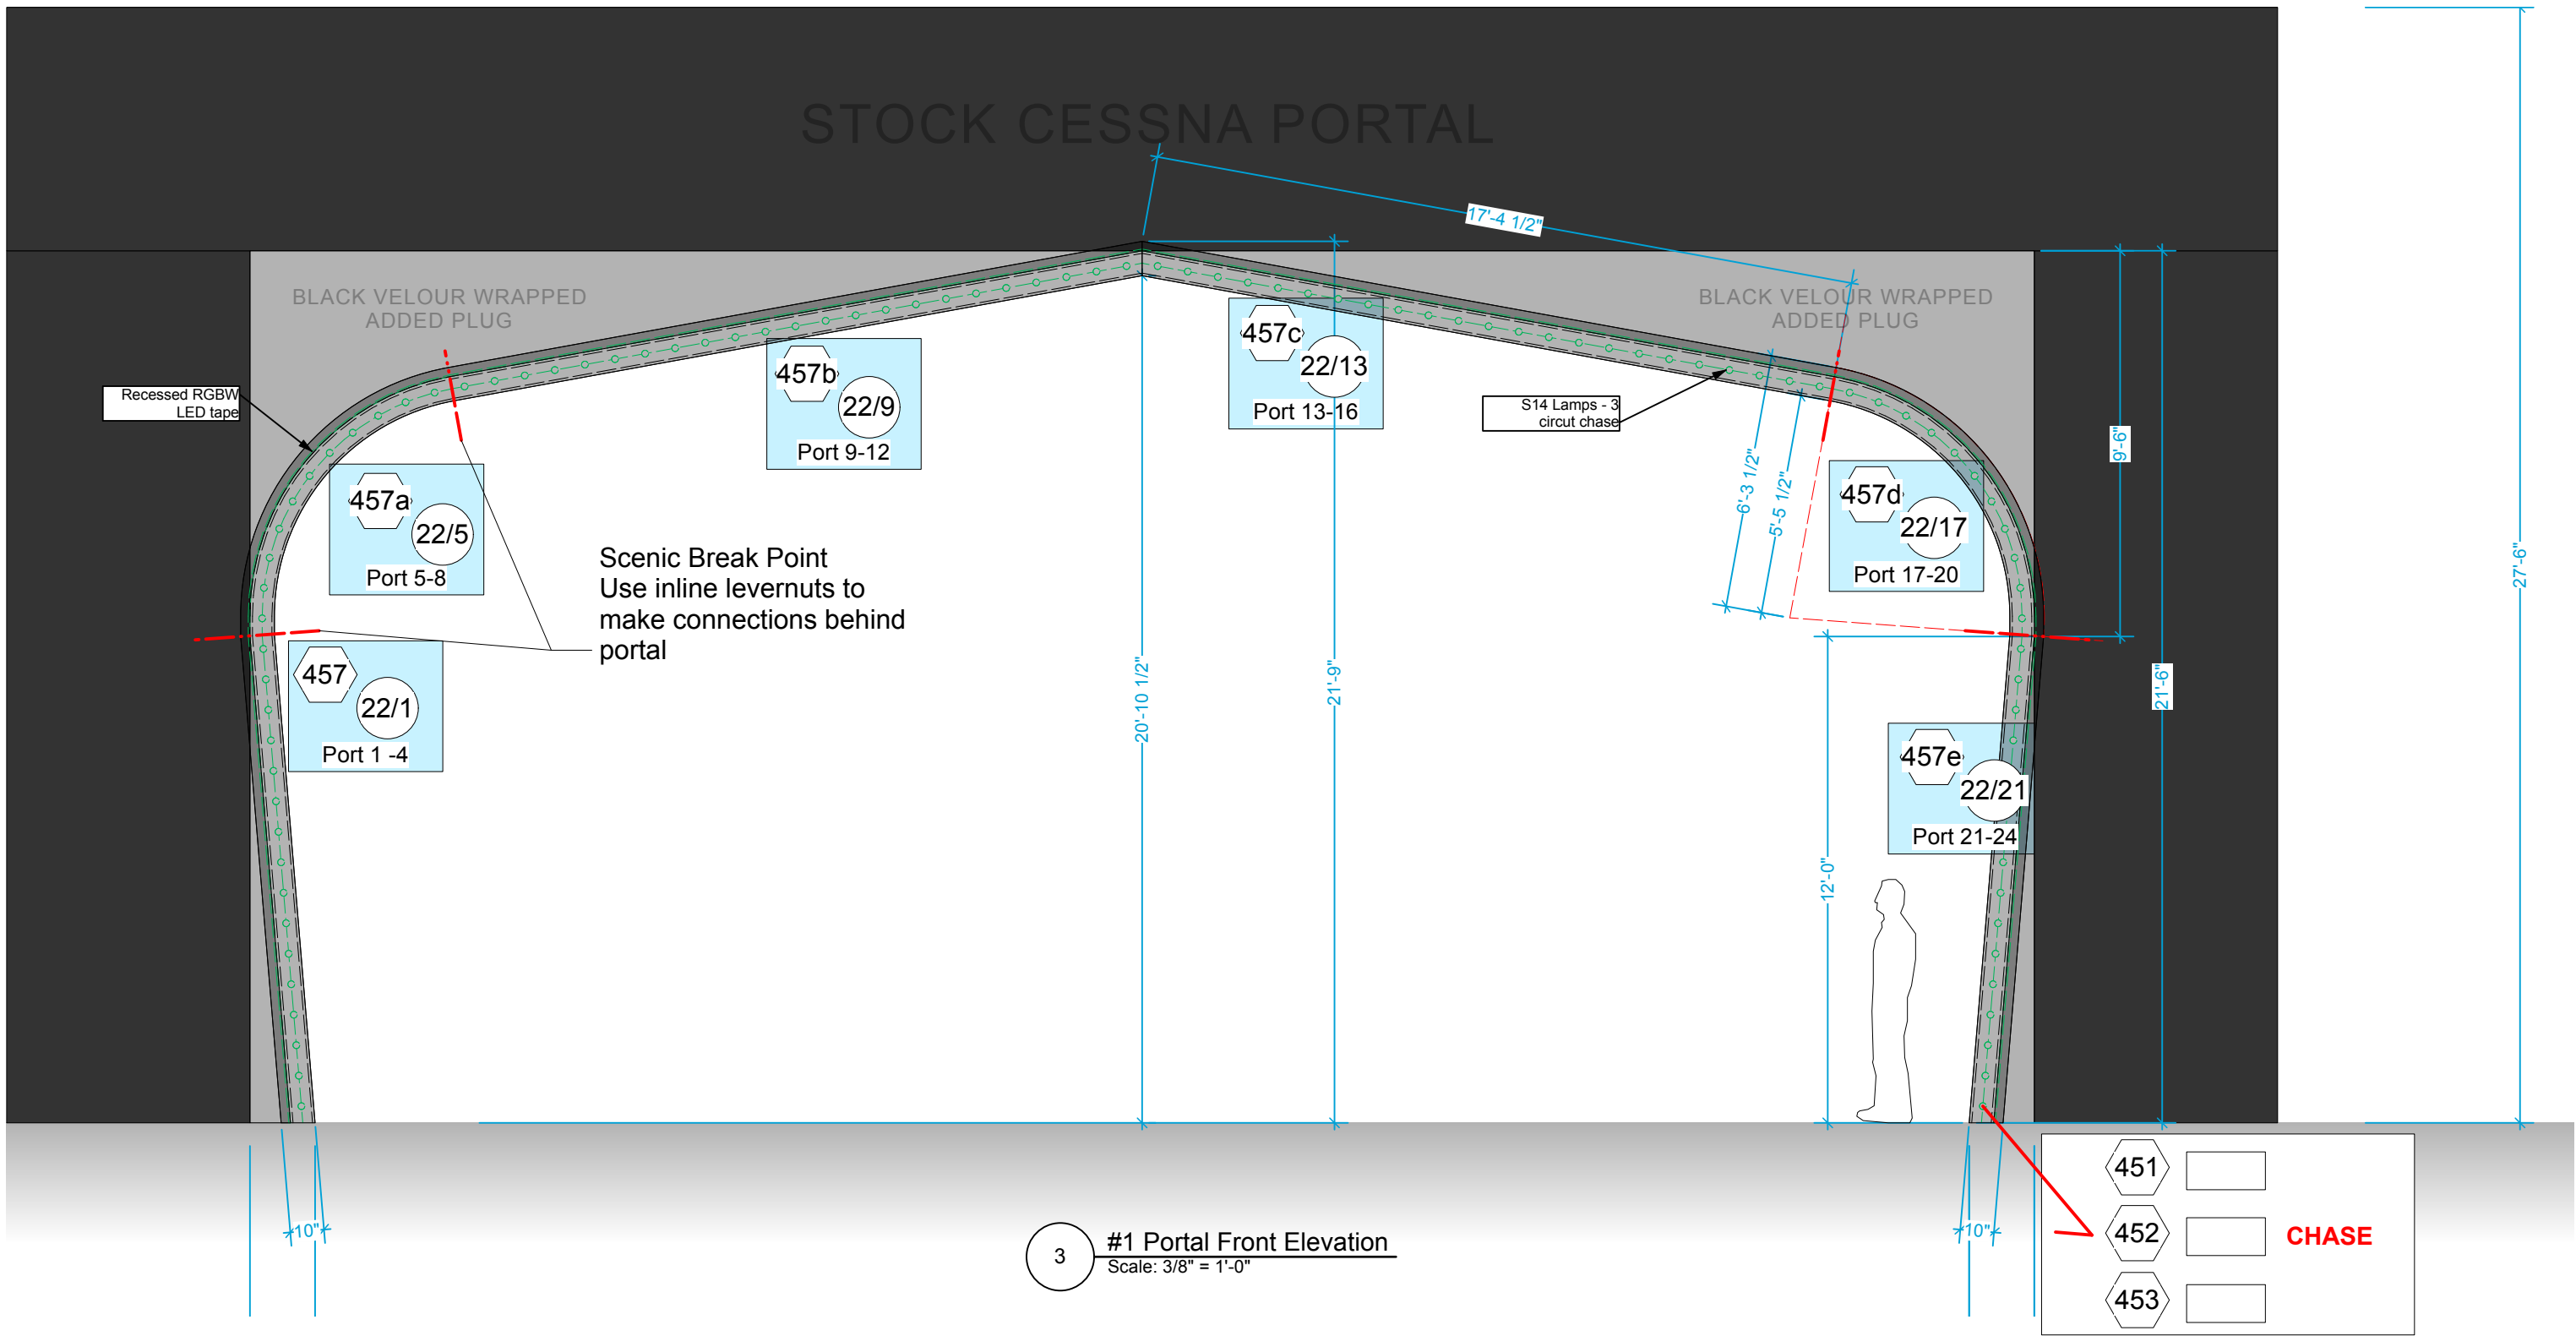


3 #1 Portal Front Elevation
Scale: 3/8" = 1'-0"

451	☐	
452	☐	CHASE
453	☐	

Position		CESSNA		
Lineset	Date	Production	FOR:	
Deck	8/2/25	Something Rotten	Hang	
SCALE	1:32	Trim	N/A	SHEET Sht-1 OF 33

CONTROL

24ch Decoder - E
@ 23/177

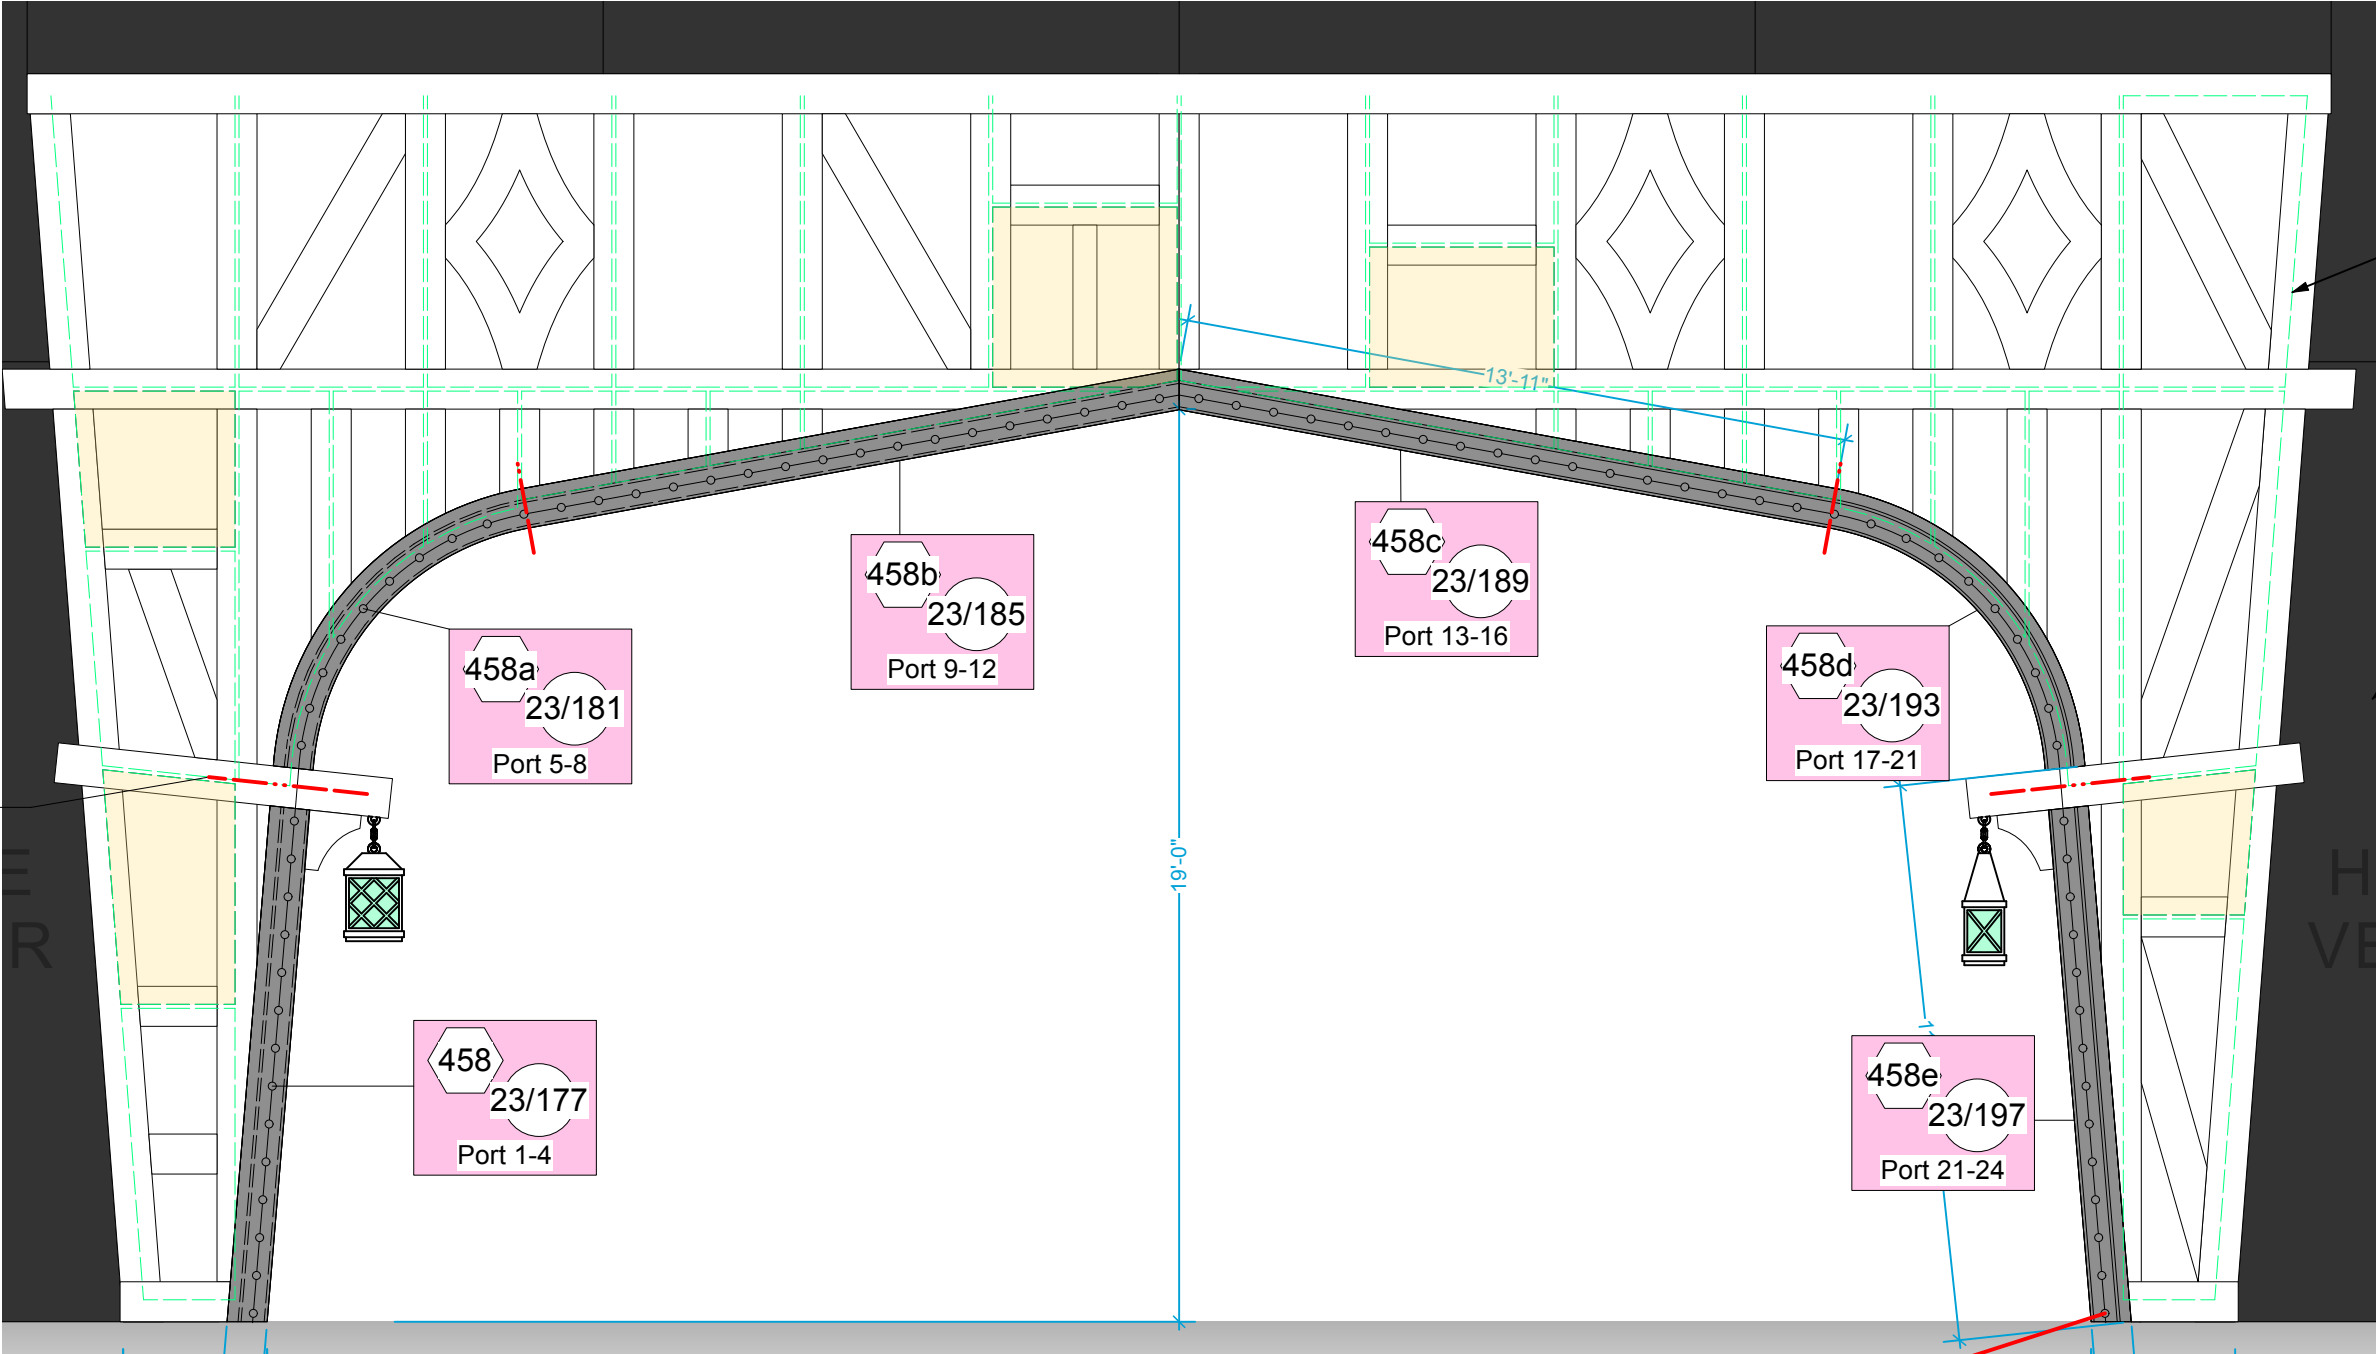

CHASE	454	☐
	455	☐
	456	☐

Position				PORTAL 2 - GLOW AND CHASE		
Lineset	Date	Production		FOR:		
Deck	8/2/25	Something Rotten		Hang		
SCALE	1:32	Trim	N/A	SHEET Sht-2 OF 33		

CONTROL

32ch Decoder - B

@ 23/01

24ch Decoder - C

@ 23/33

32ch Decoder - D

@ 23/57

32ch Decoder - F


@ 23/89

24ch Decoder - G

@ 23/121

32ch Decoder - H

@ 23/145


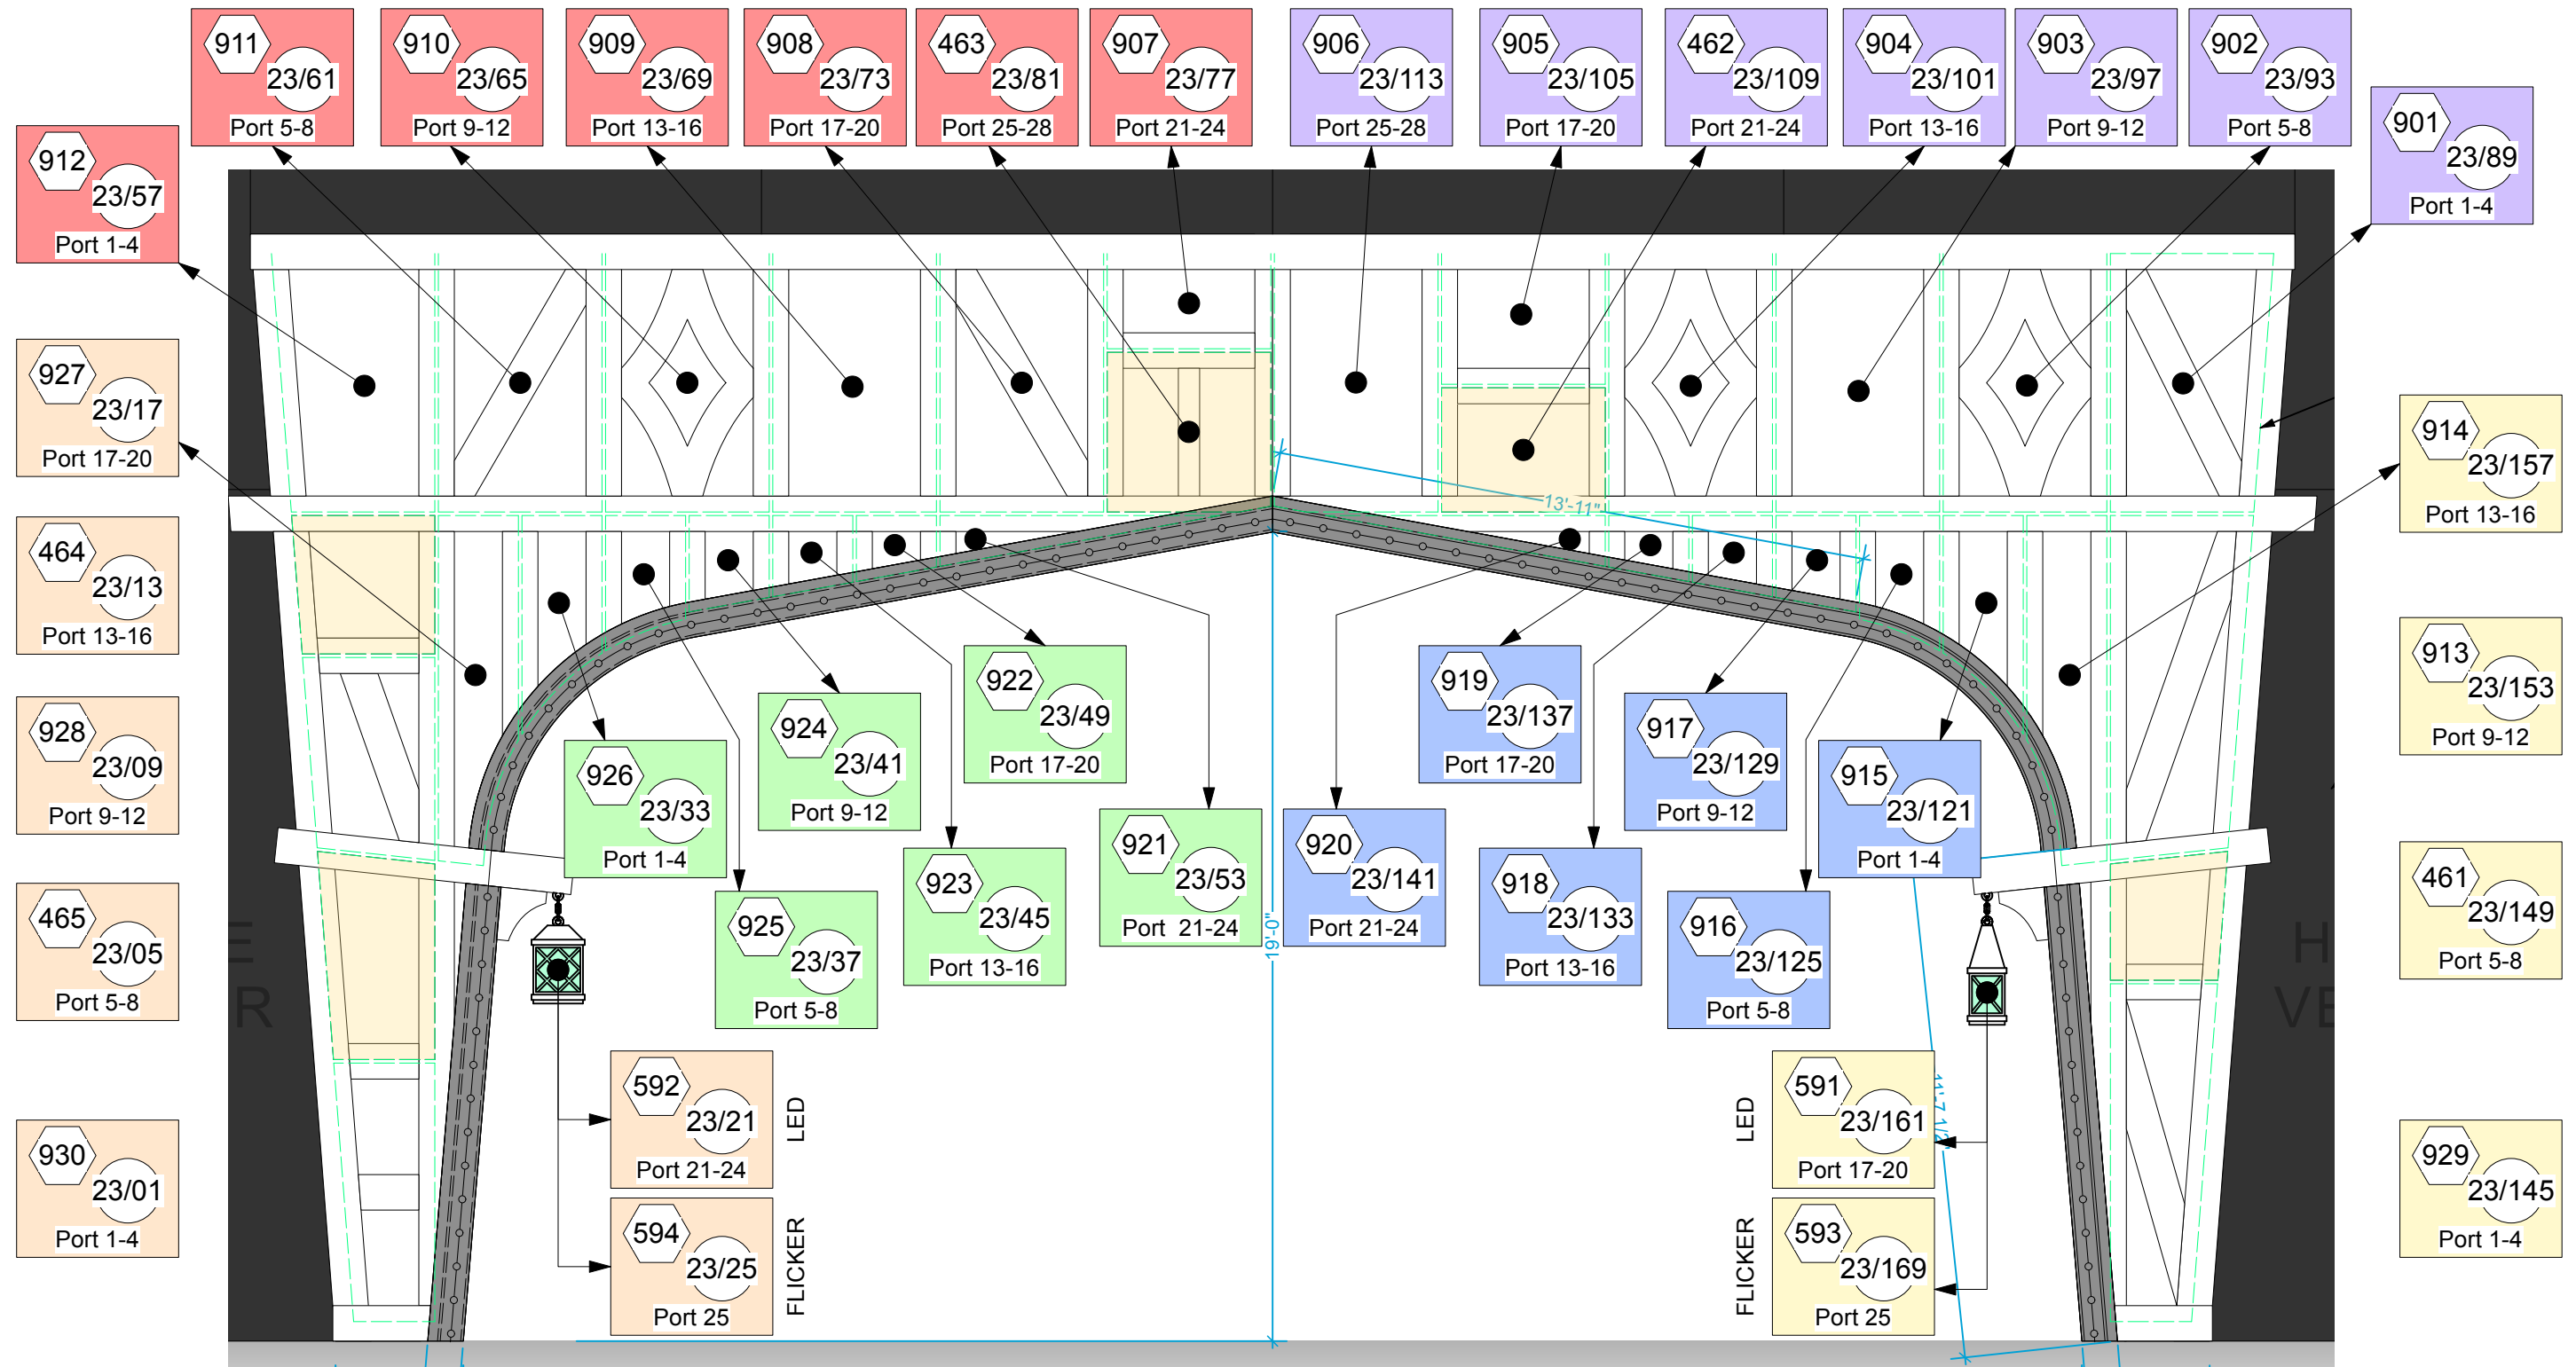


Position				PORTAL 2 - LIGHTBOXES			
Lineset		Date		Production		FOR:	
Deck		8/2/25		Something Rotten		Hang	
SCALE		1:32		Trim		N/A	
SHEET		Sht-3		OF		33	

LeDMX Controller 01
Port 1 @ 101/1
Port 2 @ 102/1

LeDMX Controller 02
Port 1 @ 103/1
Port 2 @ 104/1

CONTROL

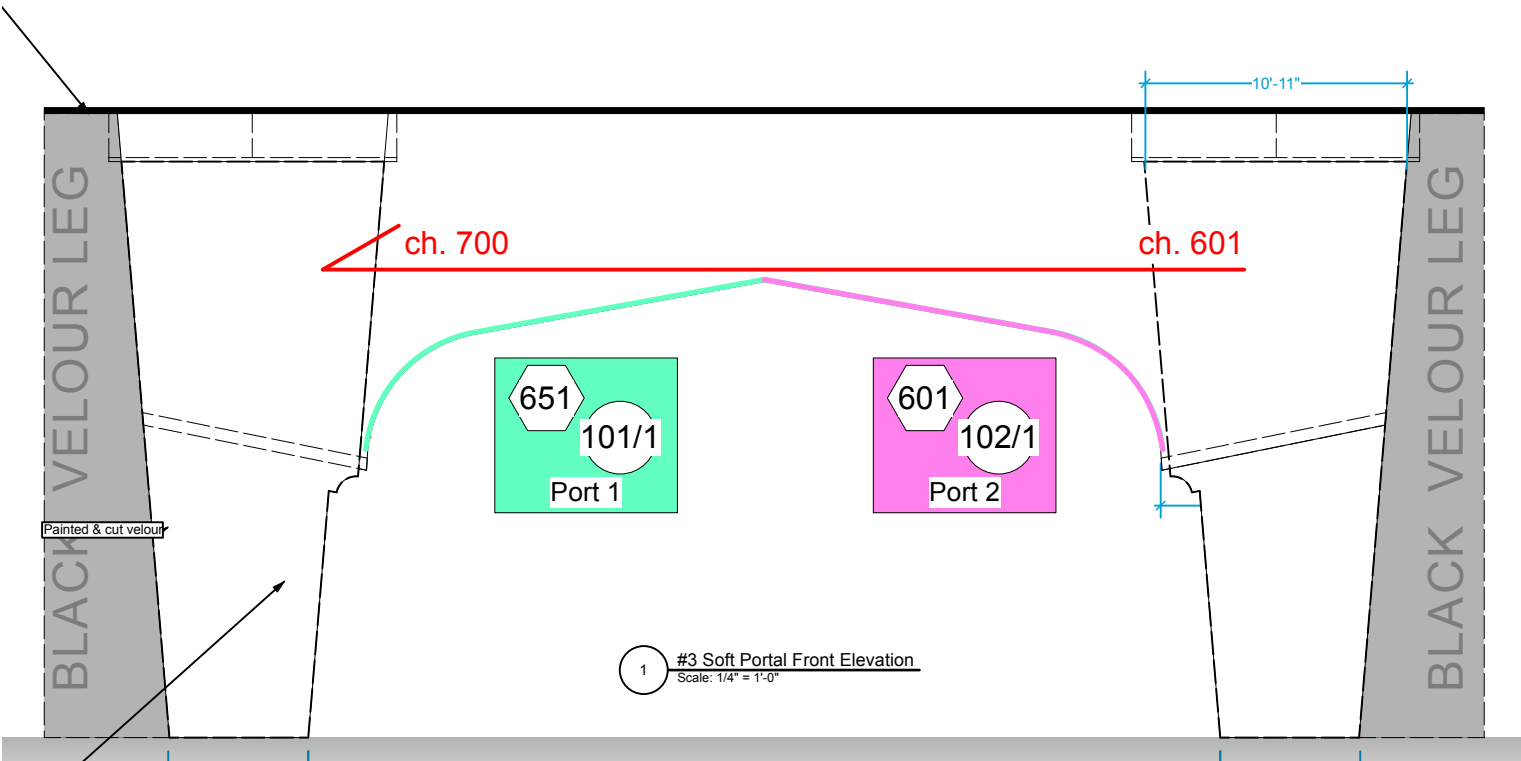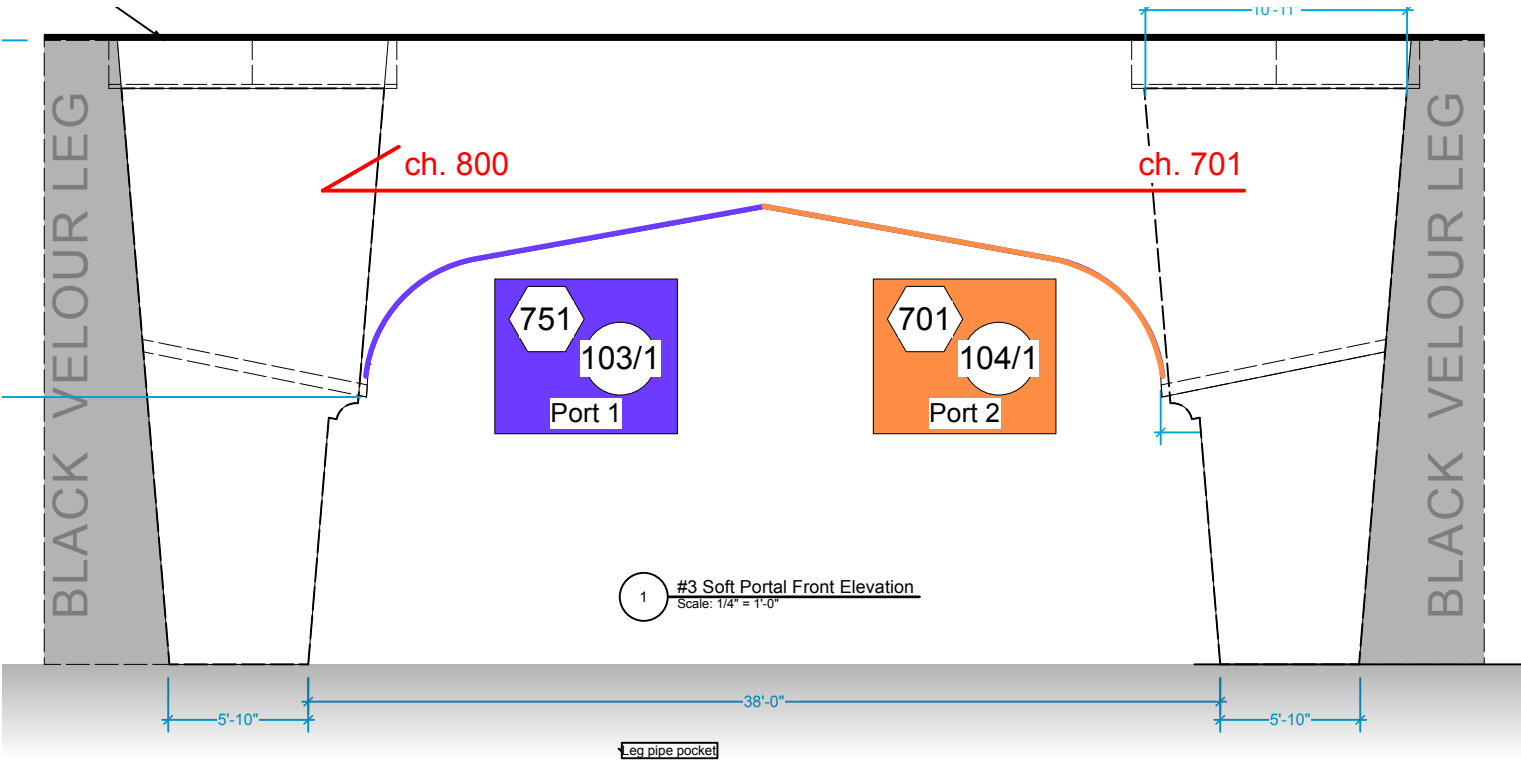

Position				PORTAL 3 + PORTAL 4	
Lineset	Date	Production		FOR:	
Deck	8/2/25	Something Rotten		Hang	
SCALE	1:32	Trim	N/A	SHEET	Sht-4 OF 33

CONTROL

LeDMX Controller 03

Port 1 @ 105/1

Port 2 @ 106/1



Position BRIDGE PORTAL			
Lineset Deck	Date 8/2/25	Production Something Rotten	FOR: Hang
SCALE 1:32	Trim N/A	SHEET Sht-5 OF 33	


CONTROL

32ch Decoder - I

@ 22/25

24ch Decoder - J

@ 22/57

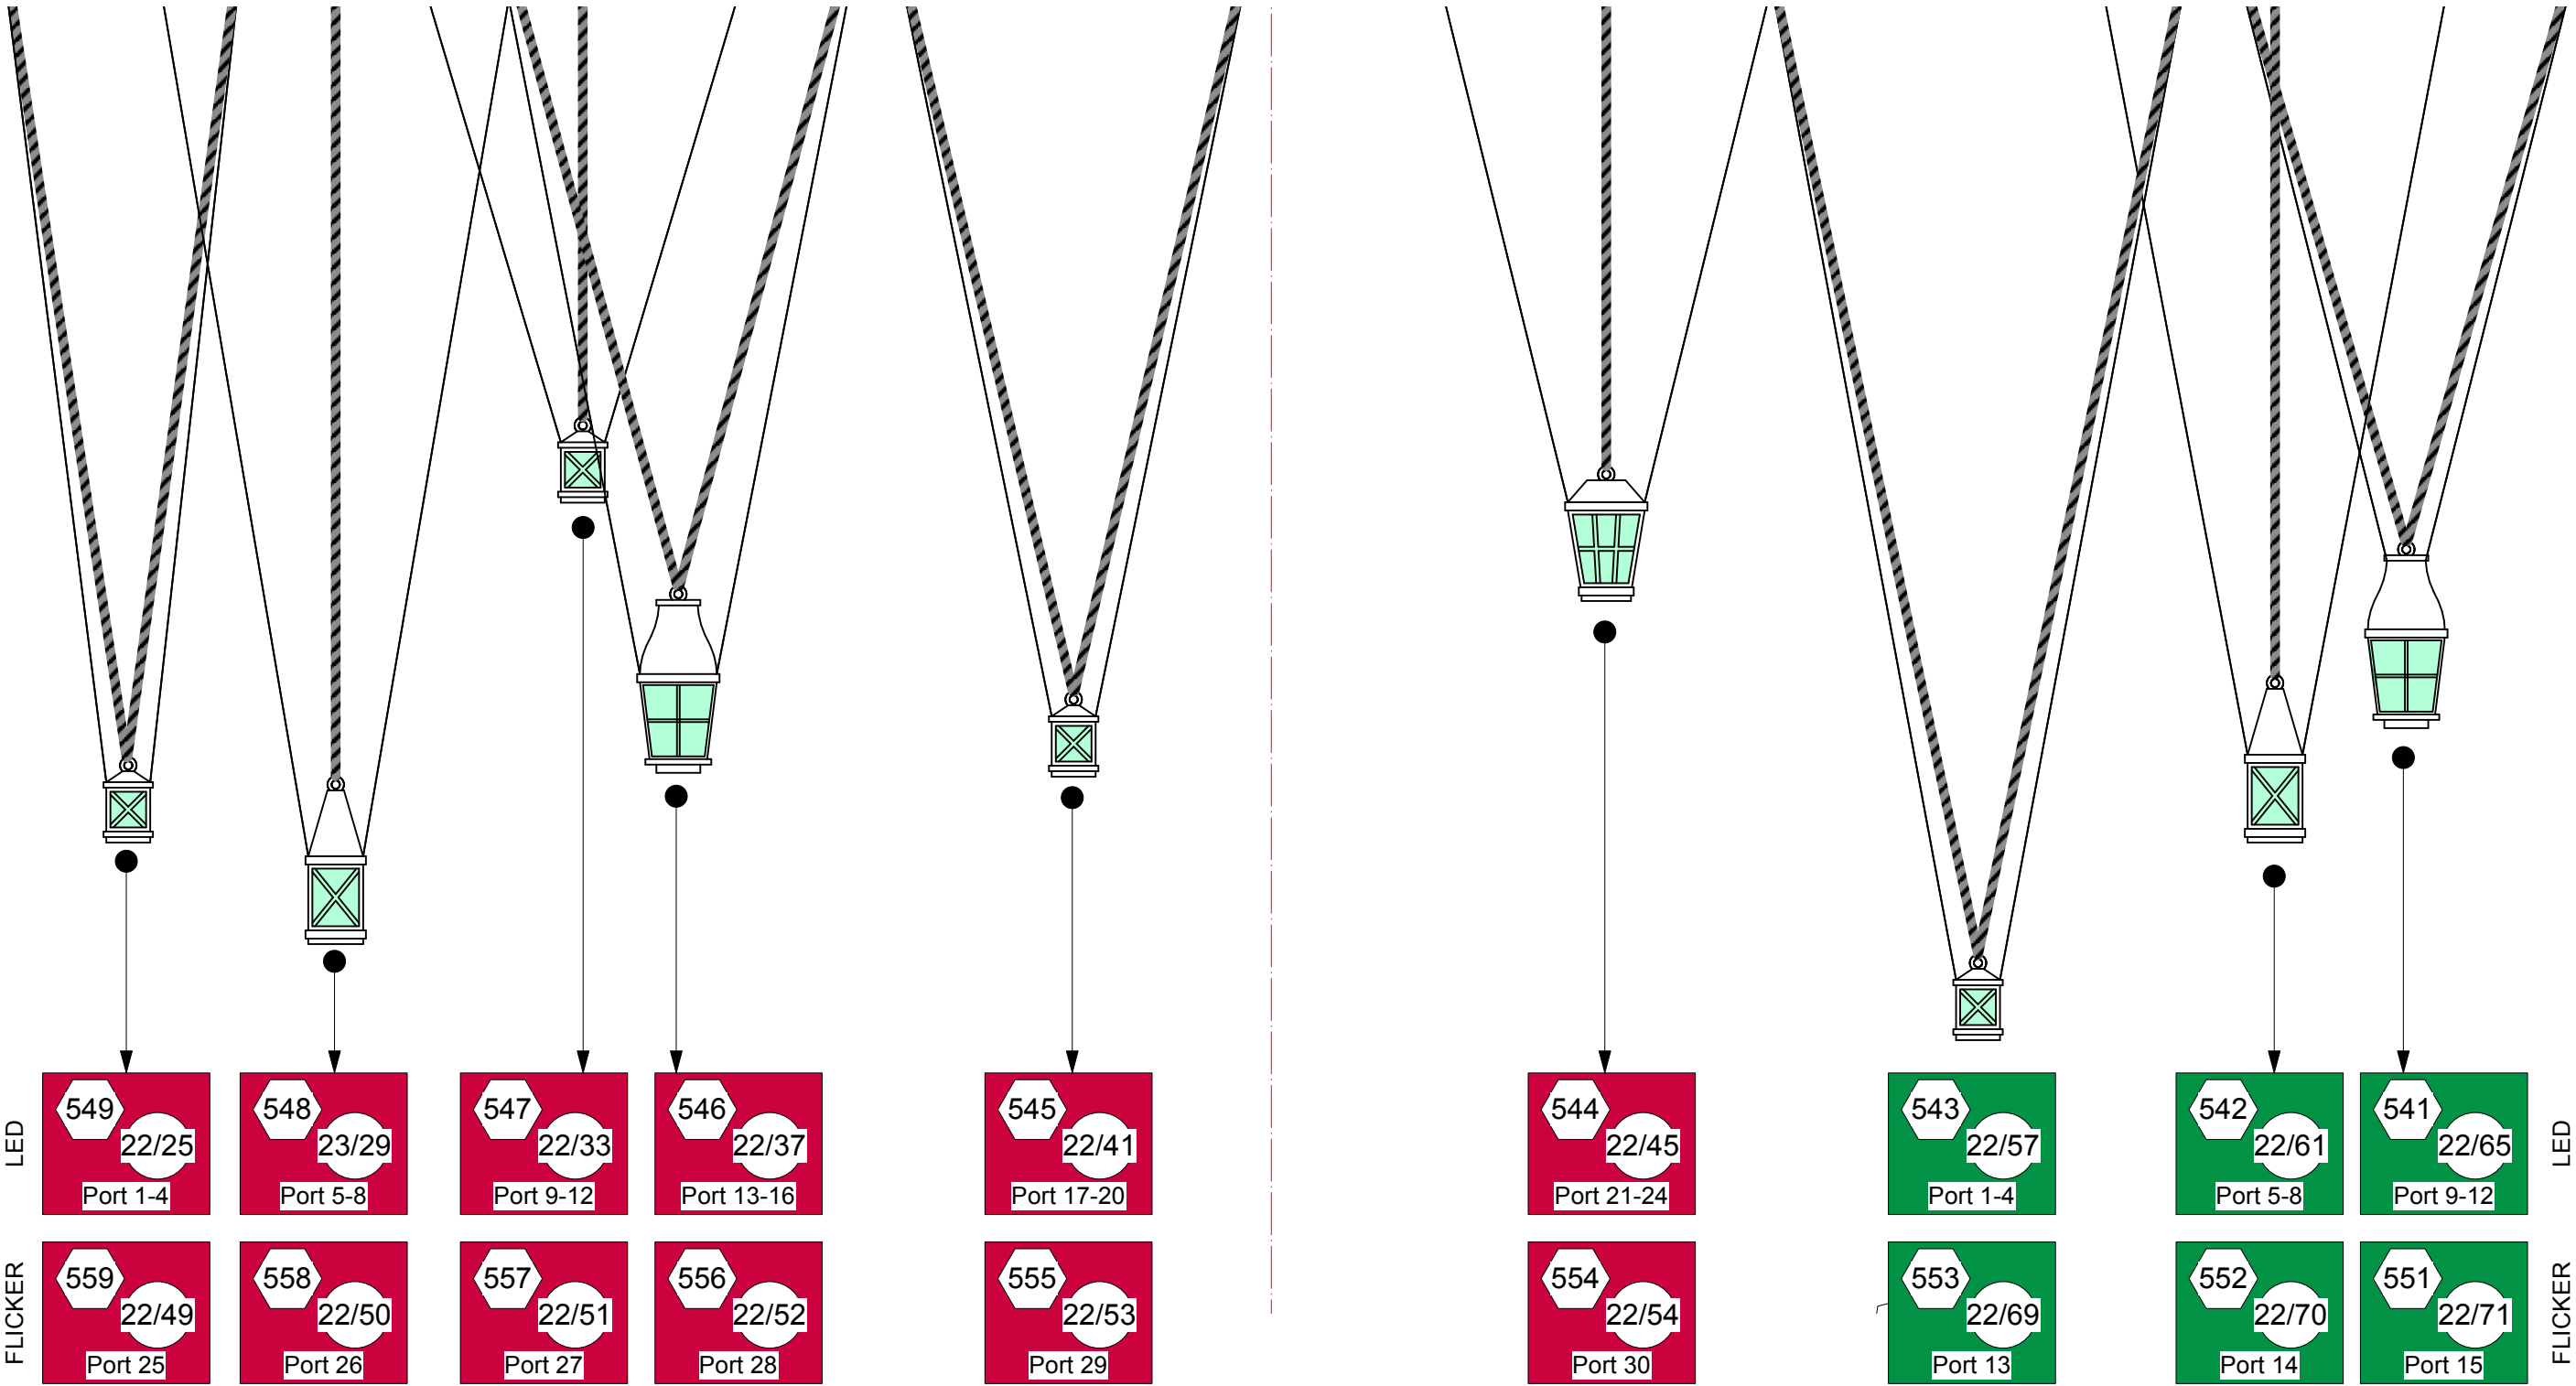


Position				TITLE SIGN / LANTERNS			
Lineset	Date		Production		FOR:		
Deck	8/2/25		Something Rotten		Hang		
SCALE	1:32		Trim	N/A		SHEET Sht-6 OF 33	

CONTROL

32ch Decoder - K

@ 22/101

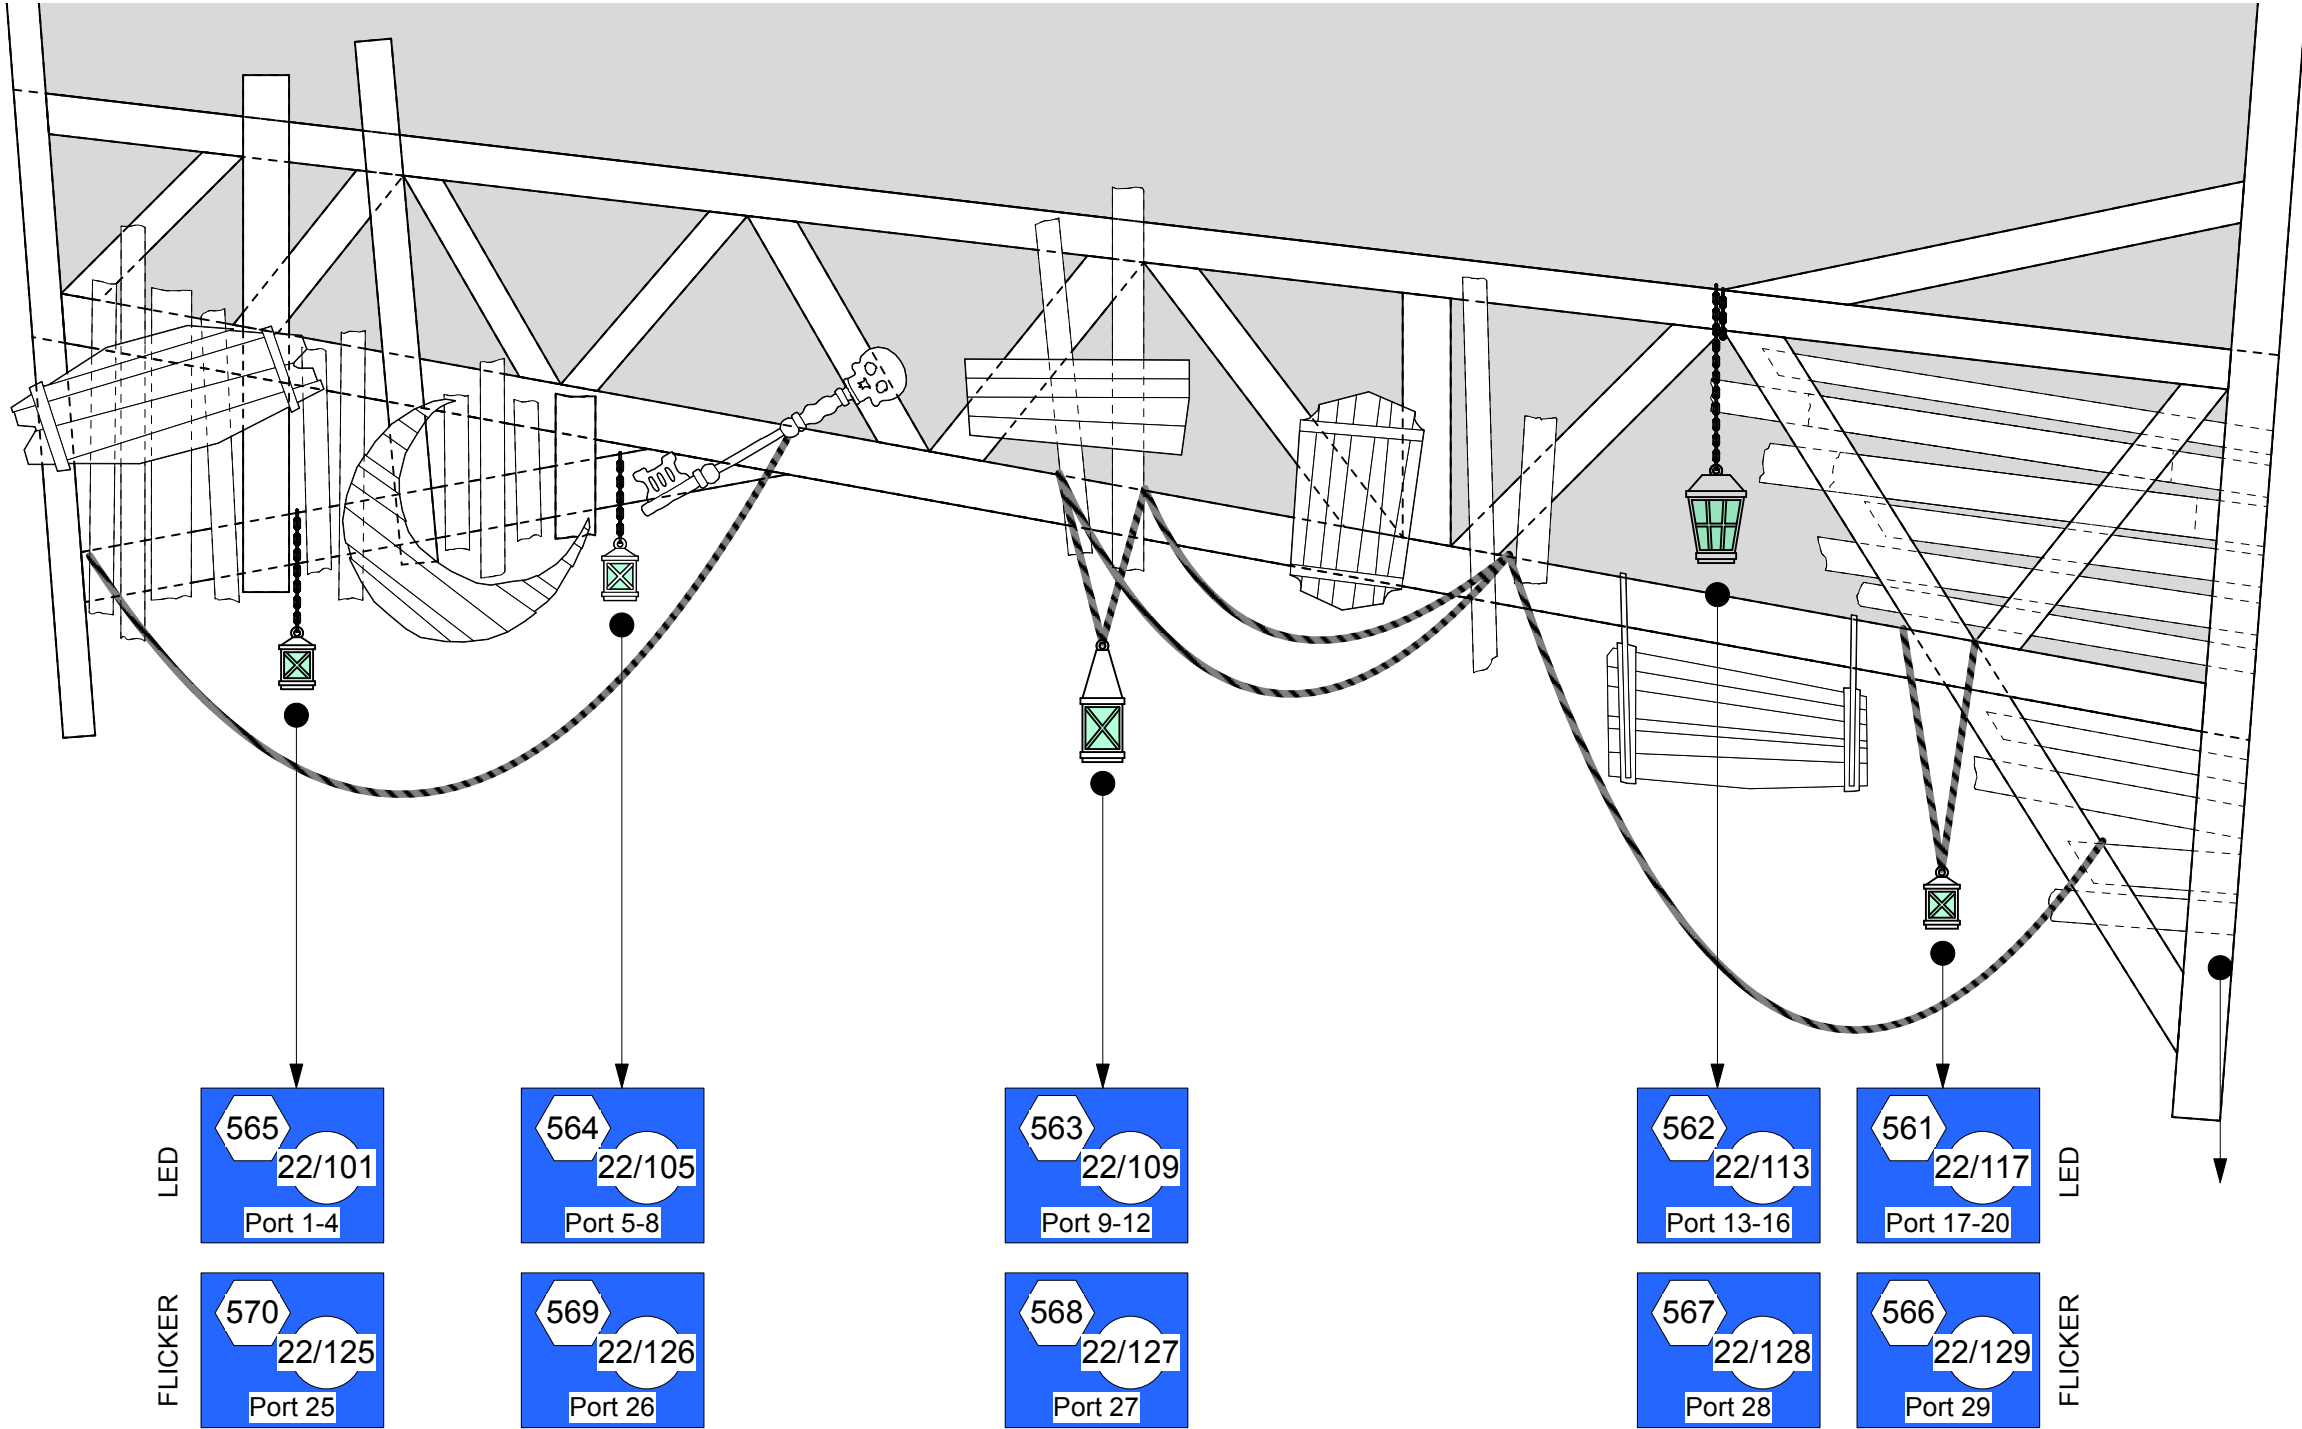

Position				ALLEY HANGER	
Lineset	Date	Production		FOR:	
Deck	8/2/25	Something Rotten		Hang	
SCALE	1:32	Trim	N/A	SHEET	Sht-7 OF 33


CONTROL

24ch Decoder - L
@ 31/1

24ch Decoder - M
@ 31/101

UPSTAGE

DOWNSTAGE

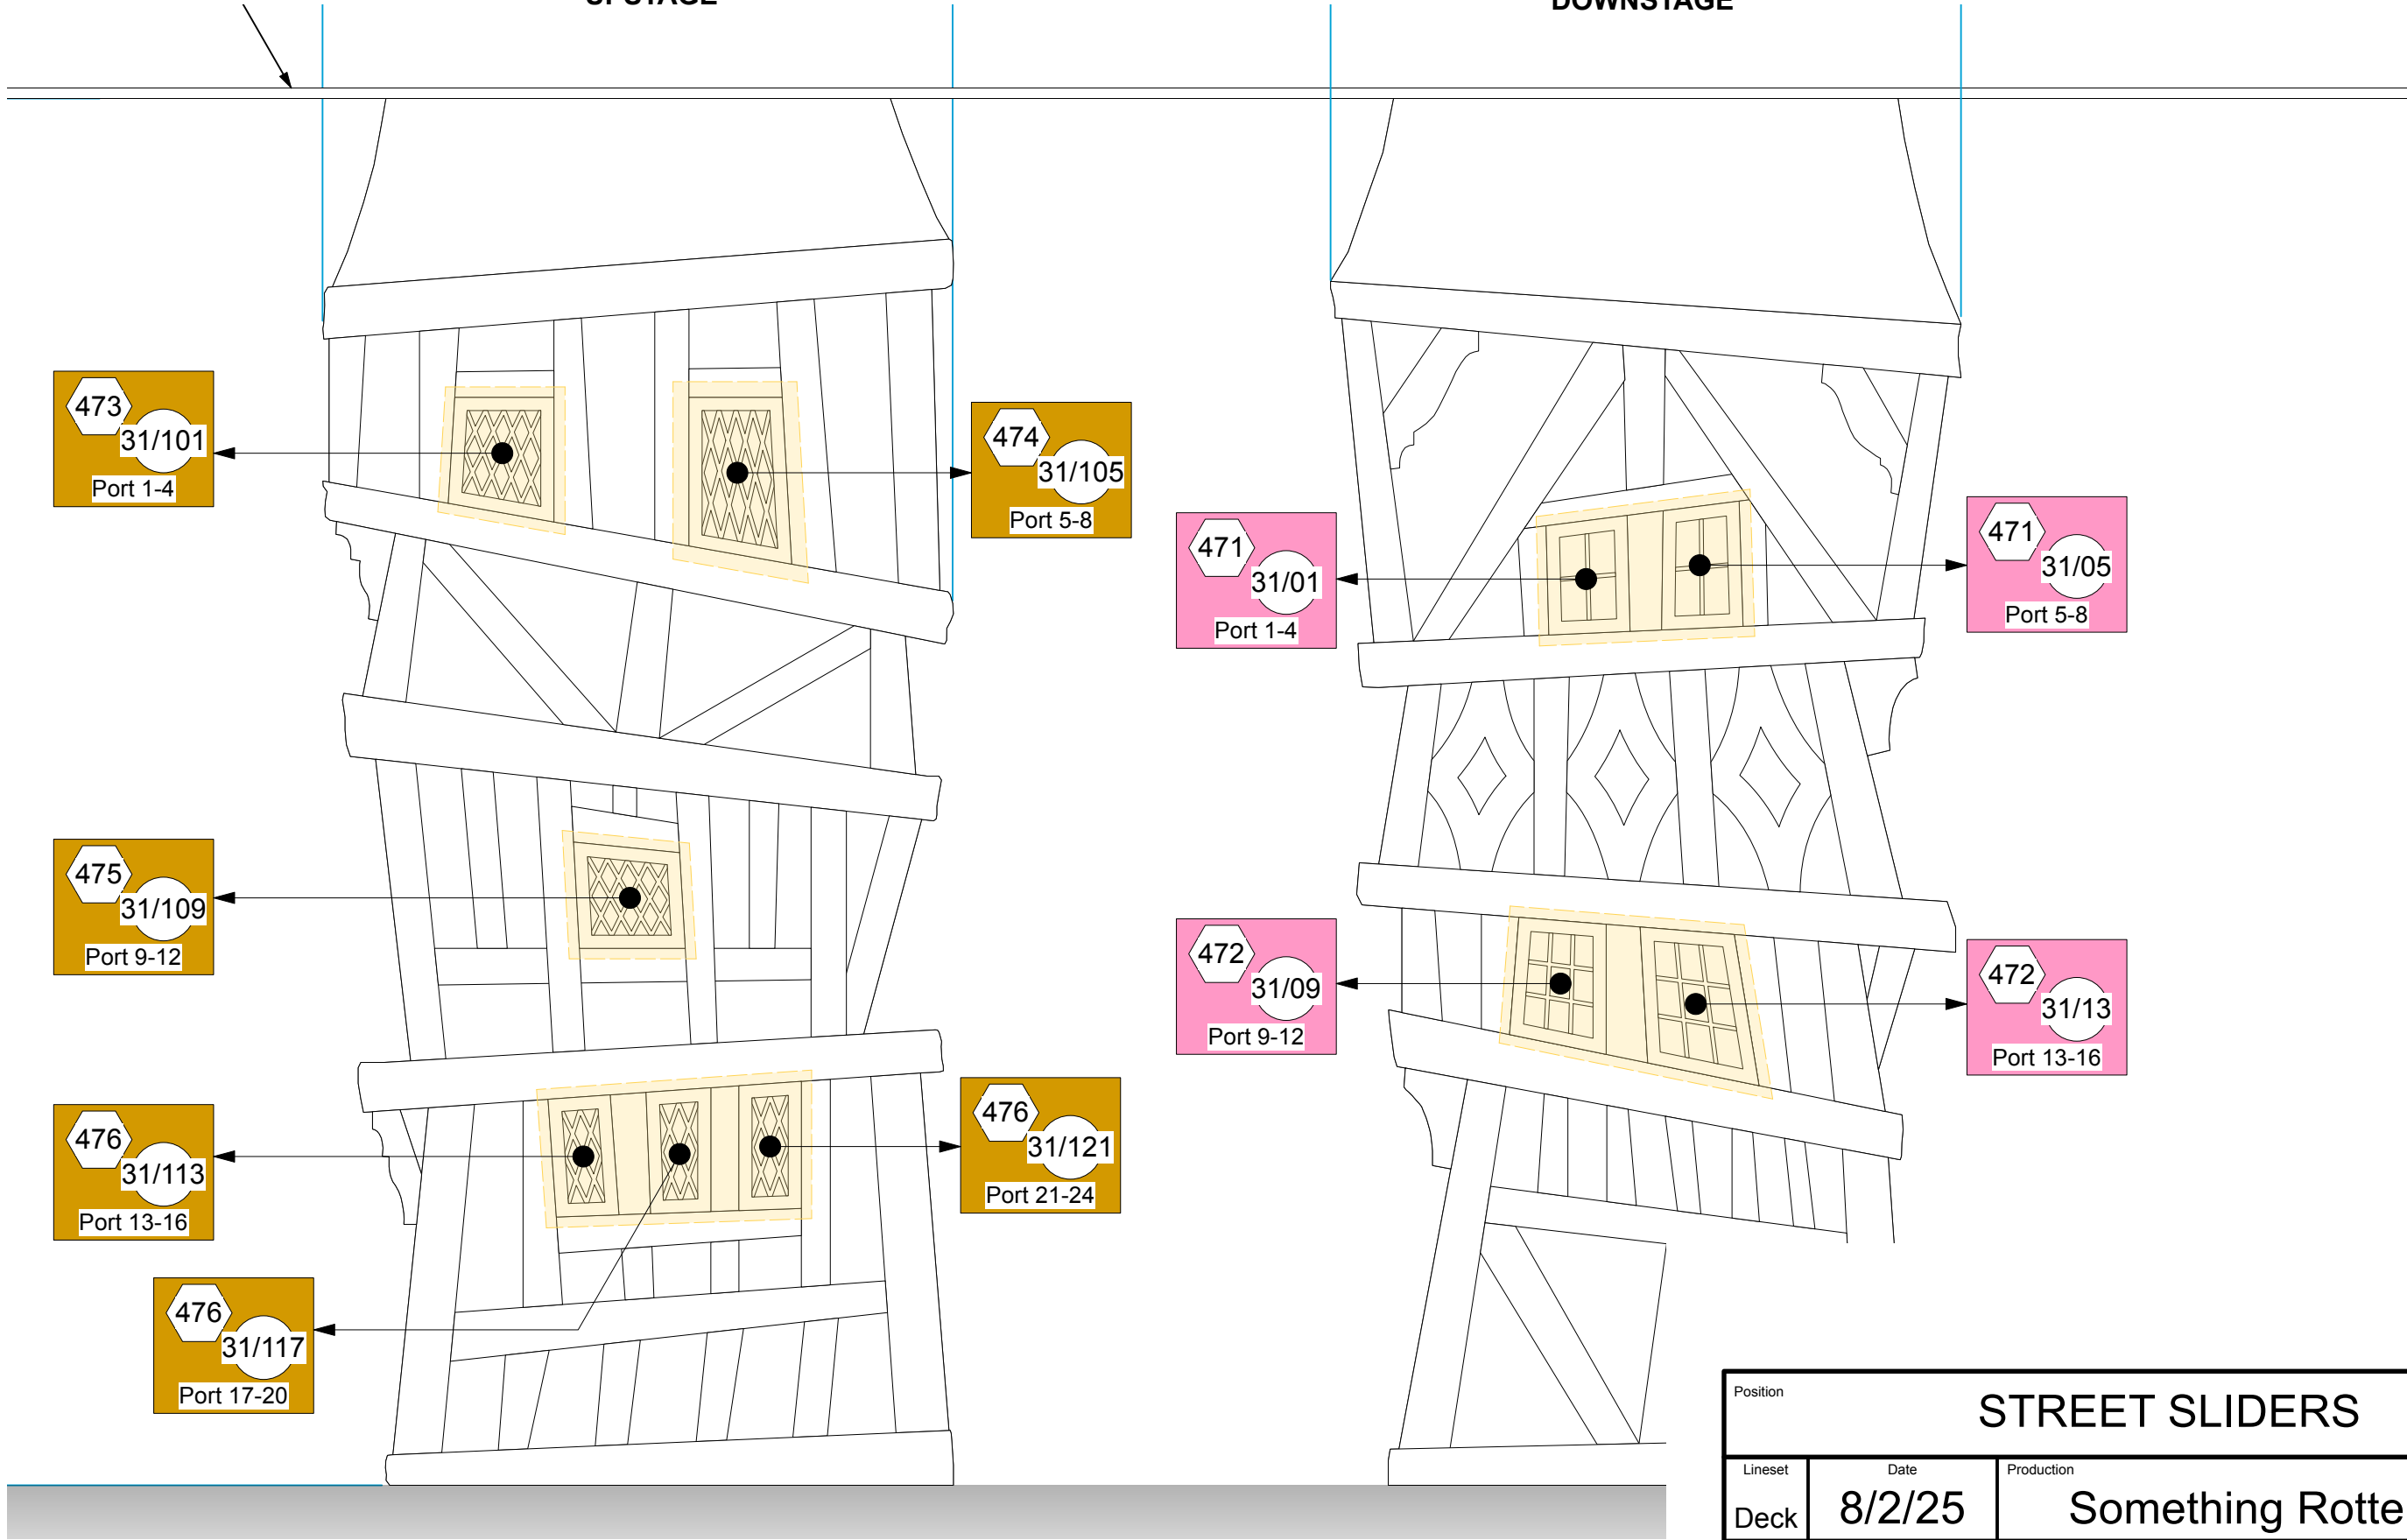


Position				STREET SLIDERS			
Lineset		Date		Production		FOR:	
Deck		8/2/25		Something Rotten		Hang	
SCALE		1:32		Trim		N/A	
SHEET		Sht-8		OF		33	

CONTROL

32ch Decoder - N
@ 26/101

32ch Decoder - O
@ 26/01

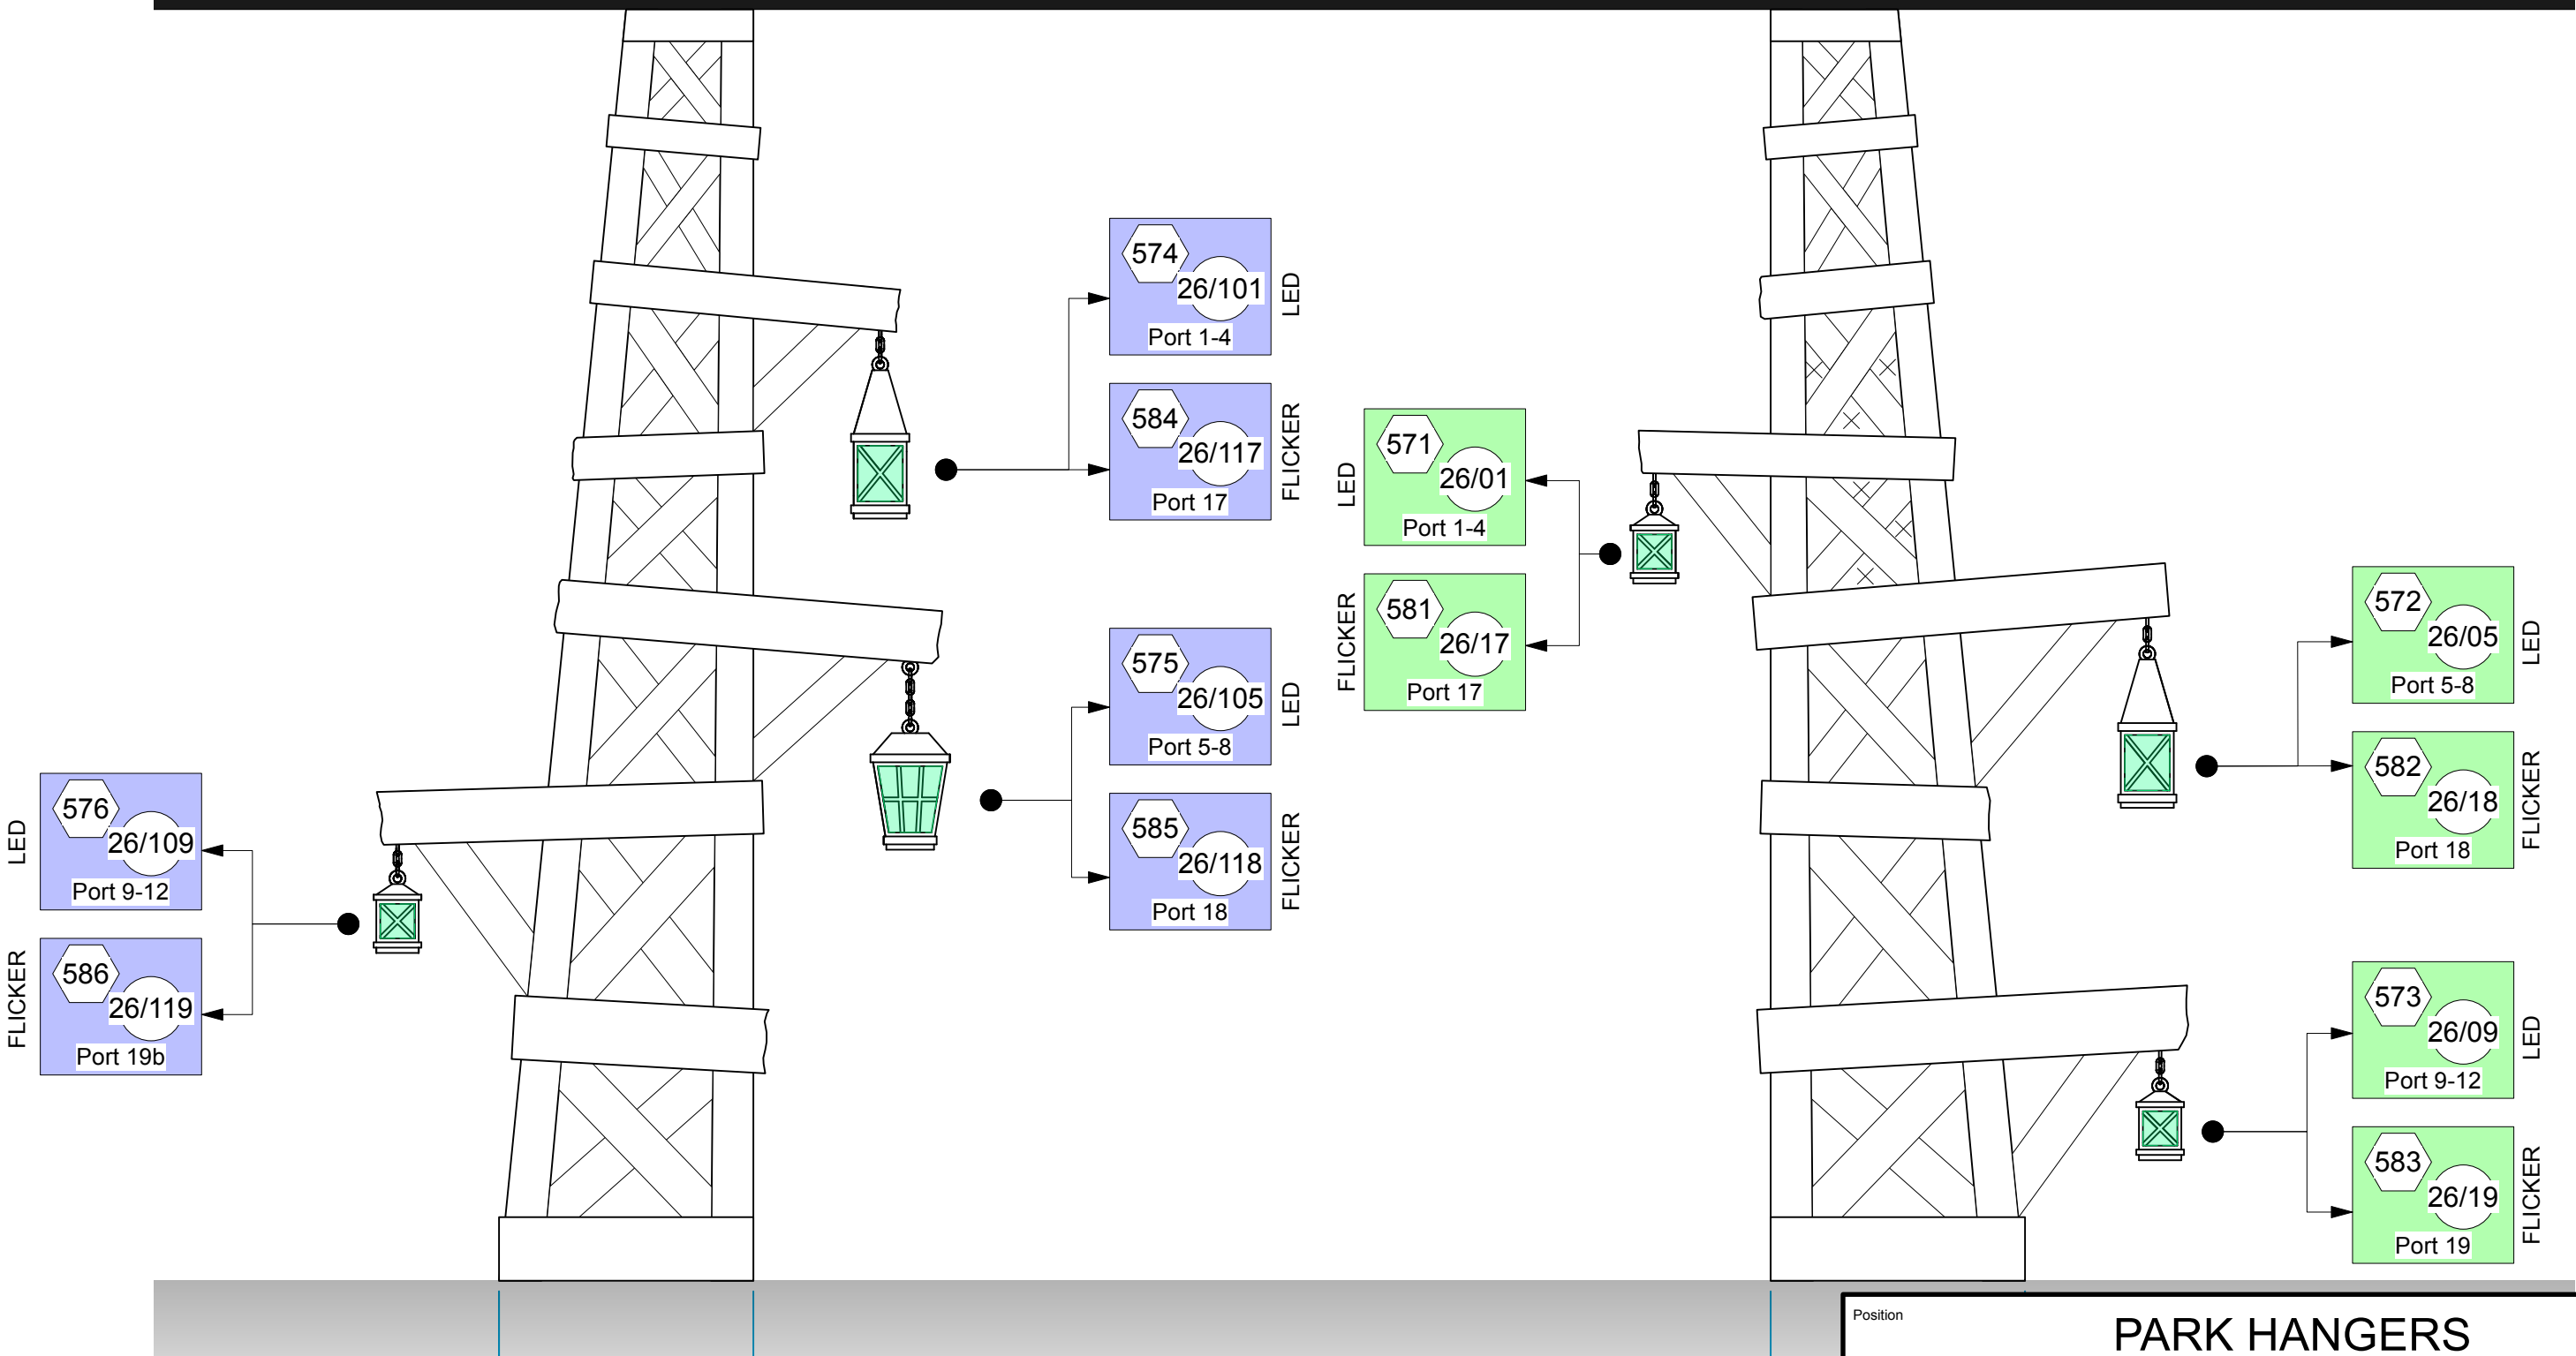

Position				PARK HANGERS			
Lineset	Date	Production		FOR:			
Deck	8/2/25	Something Rotten		Hang			
SCALE	1:32	Trim	N/A	SHEET	Sht-9	OF	33


CONTROL

QolorFlex 5ch Dimmer
@ 31/201

QOLORFLEX CONTROLLER
POWERED BY USB OUT OF
TALENCCELL BATTERY

RUN RIBBON CABLE
FROM LANTERNS TO
CONTROL BEHIND UNIT

BOTH LANTERNS ARE 3-D
PRACTICAL LANTERNS WITH
FLICKER ONLY (NO DISCO)

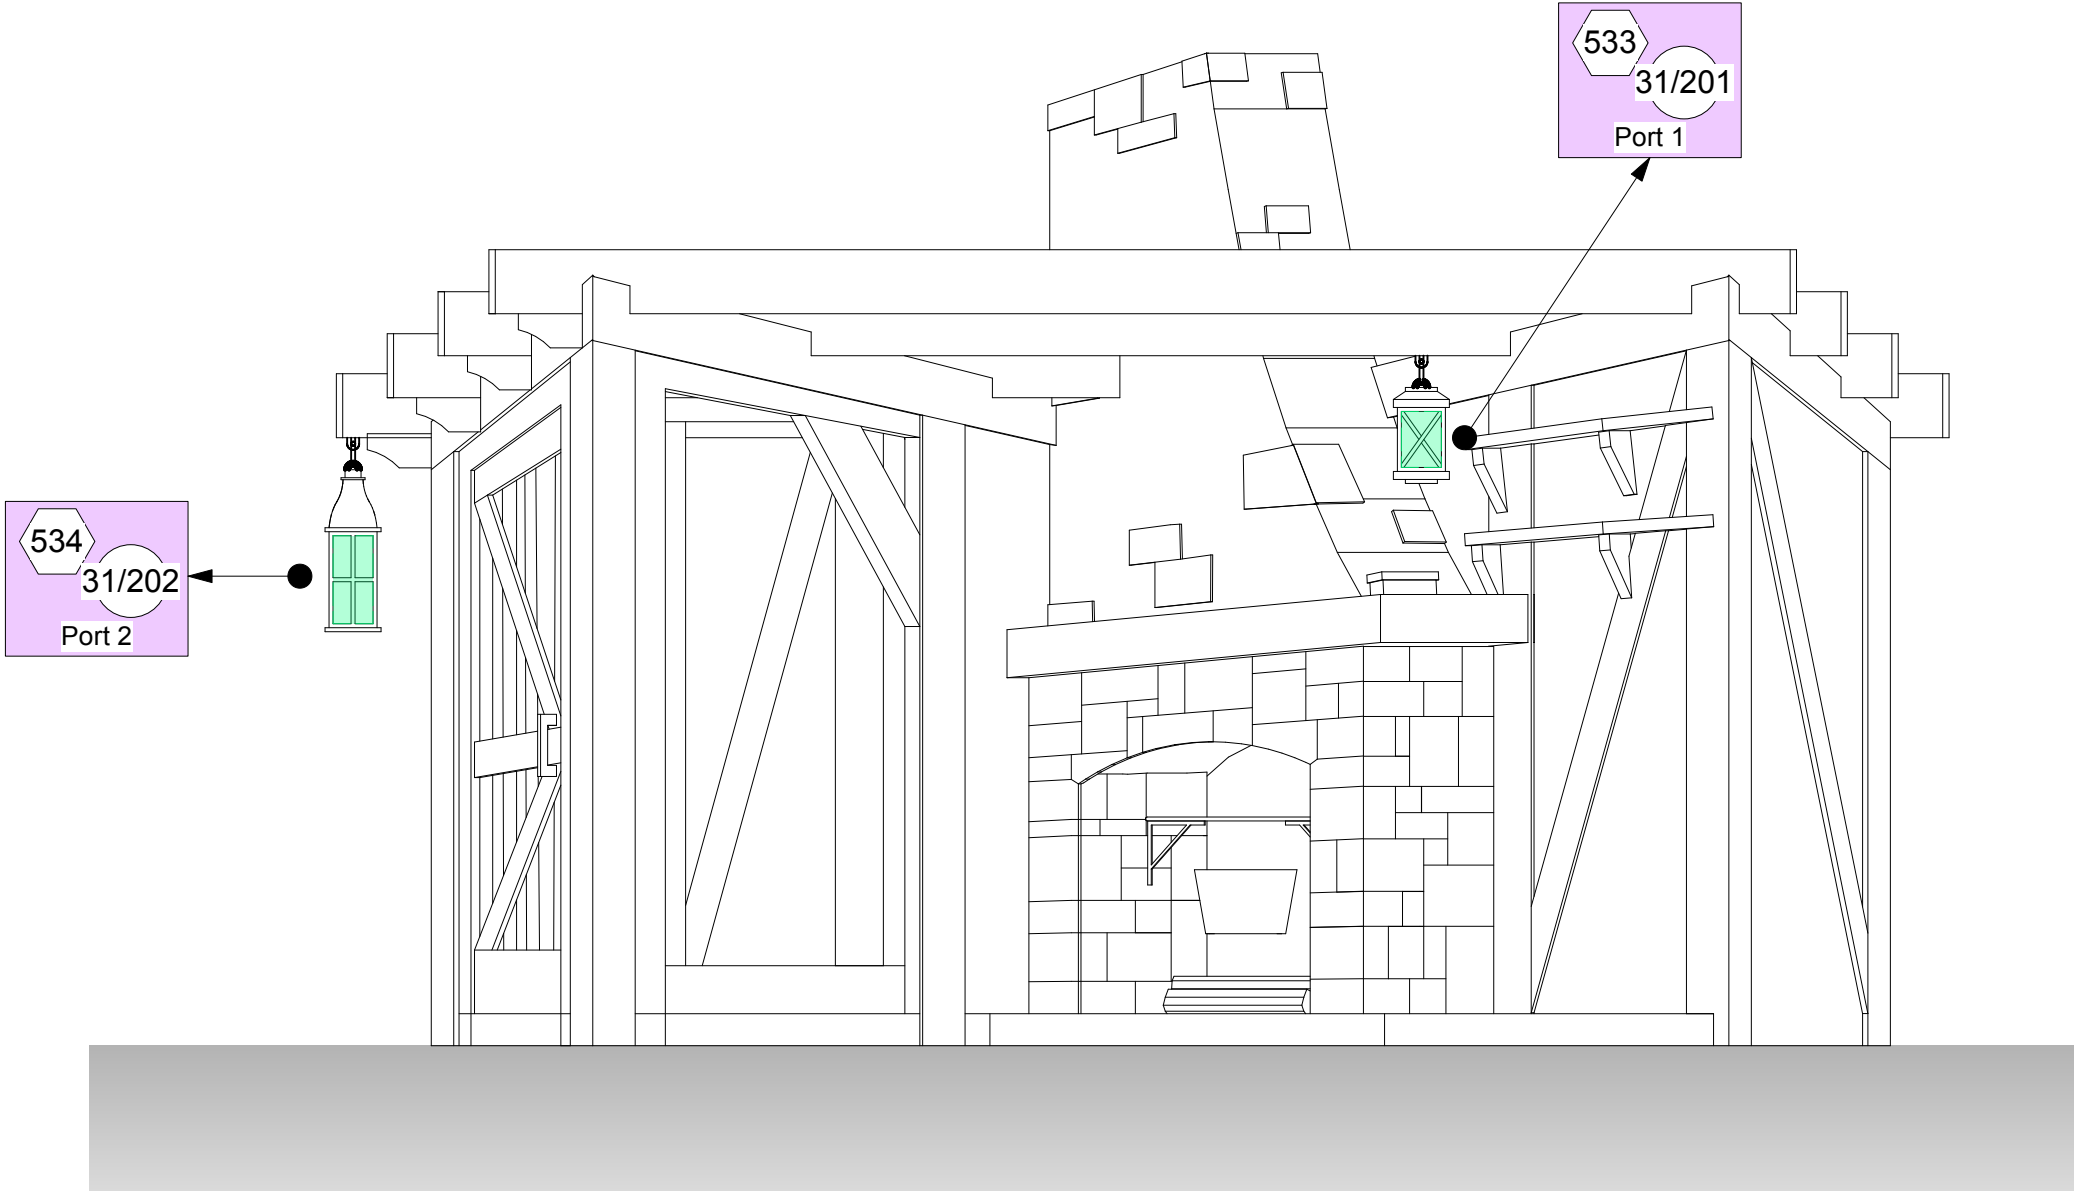

Position				NICK AND BEA'S HOUSE	
Lineset	Date	Production		FOR:	
Deck	8/2/25	Something Rotten		Hang	
SCALE	1:32	Trim	N/A	SHEET	Sht-10 OF 33

CONTROL

24ch Decoder - P

@ 31/301

2ch QolorFlex Dimmer

@ 31/401


DECODER POWERED BY 12V
BATTERY AND 5V BATTERY,
CONNECTED TO SHOWBABY

RUN RIBBON CABLE
FROM LANTERNS TO
CONTROL BEHIND UNIT

ONE 3-D PRACTICAL LANTERN,
ONE FLAT LANTERN
BOTH HAVE FLICKER AND DISCO

LED
536
31/301
Port 1-4

FLICKER
538
31/309
Port 13

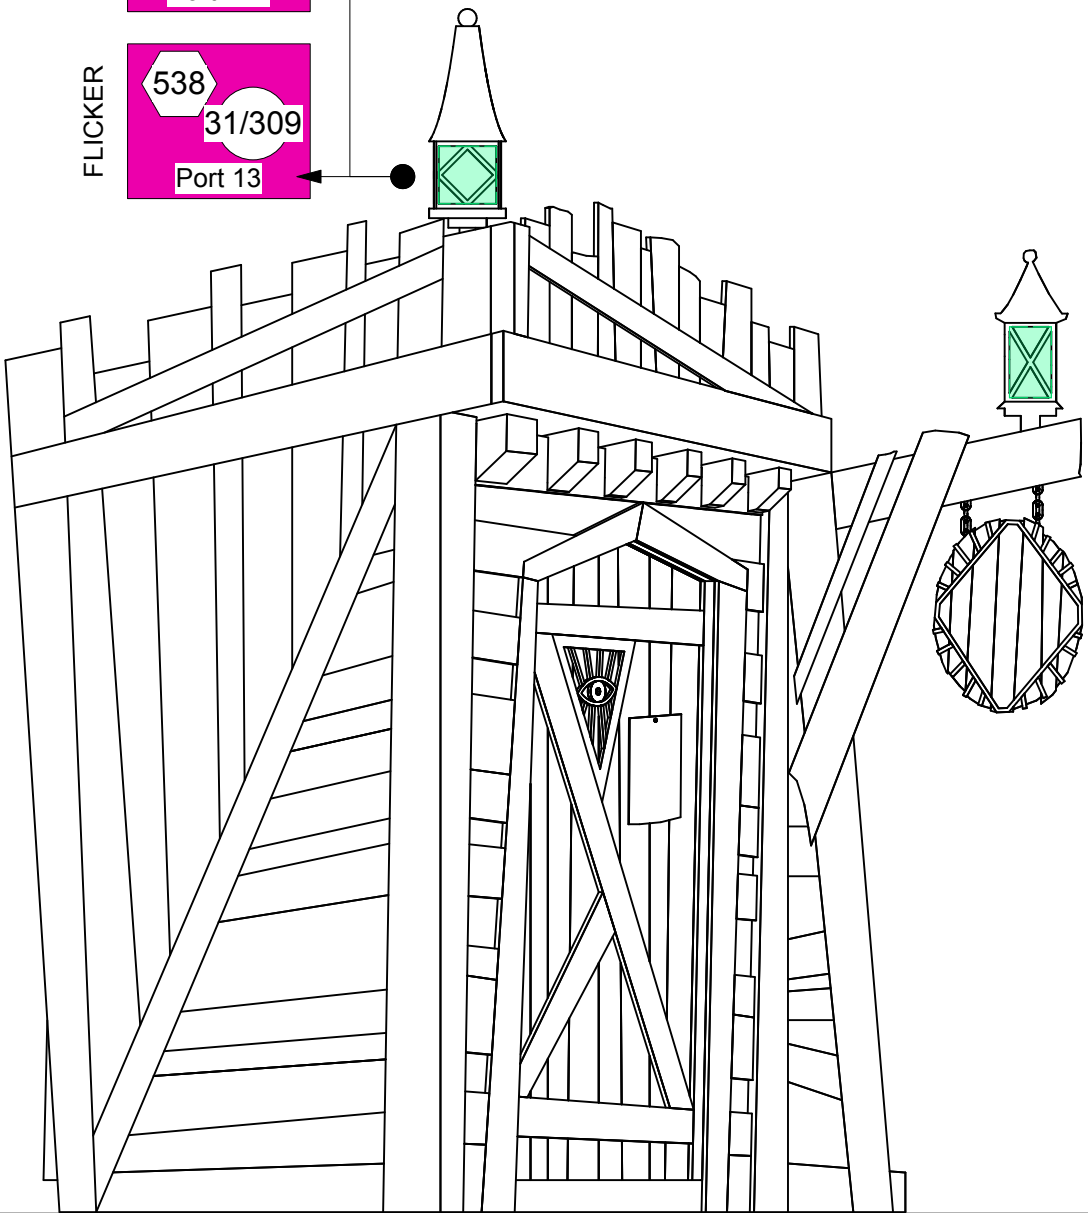


LED
535
31/305
Port 5-8

FLICKER
537
31/310
Port 14

ACTOR PRACTICAL

POWERED BY 5V BATTERY

FLICKER
595
31/402
Port 2

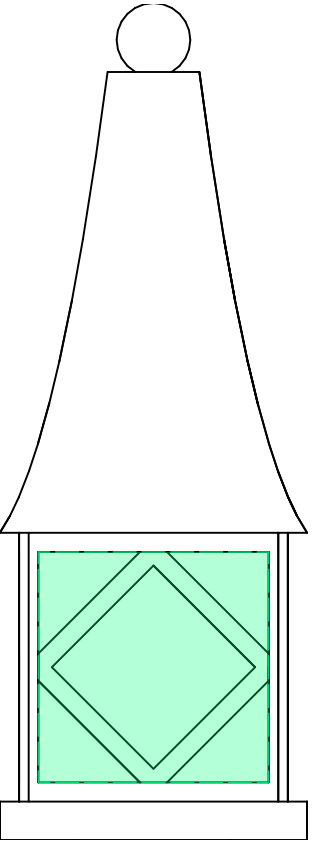

PositionTHOOTHAYER THACK + PRACTICAL			
Lineset	Date	Production	FOR:
Deck	8/2/25	Something Rotten	Hang
SCALE 1:32	Trim N/A	SHEET Sht-11 OF 33	